




Copyright, S. Watson Design, Inc. – 2016

OLERIO HOMES
7503 CAILLET STREET
LOT 9 BLOCK 9/4840
LOVERS LANE HEIGHTS
AN ADDITION TO THE CITY OF
DALLAS, DALLAS COUNTY, TX

PLAN NUMBER
9378316


DATE
9/2/2016

SHEET NUMBER
A2

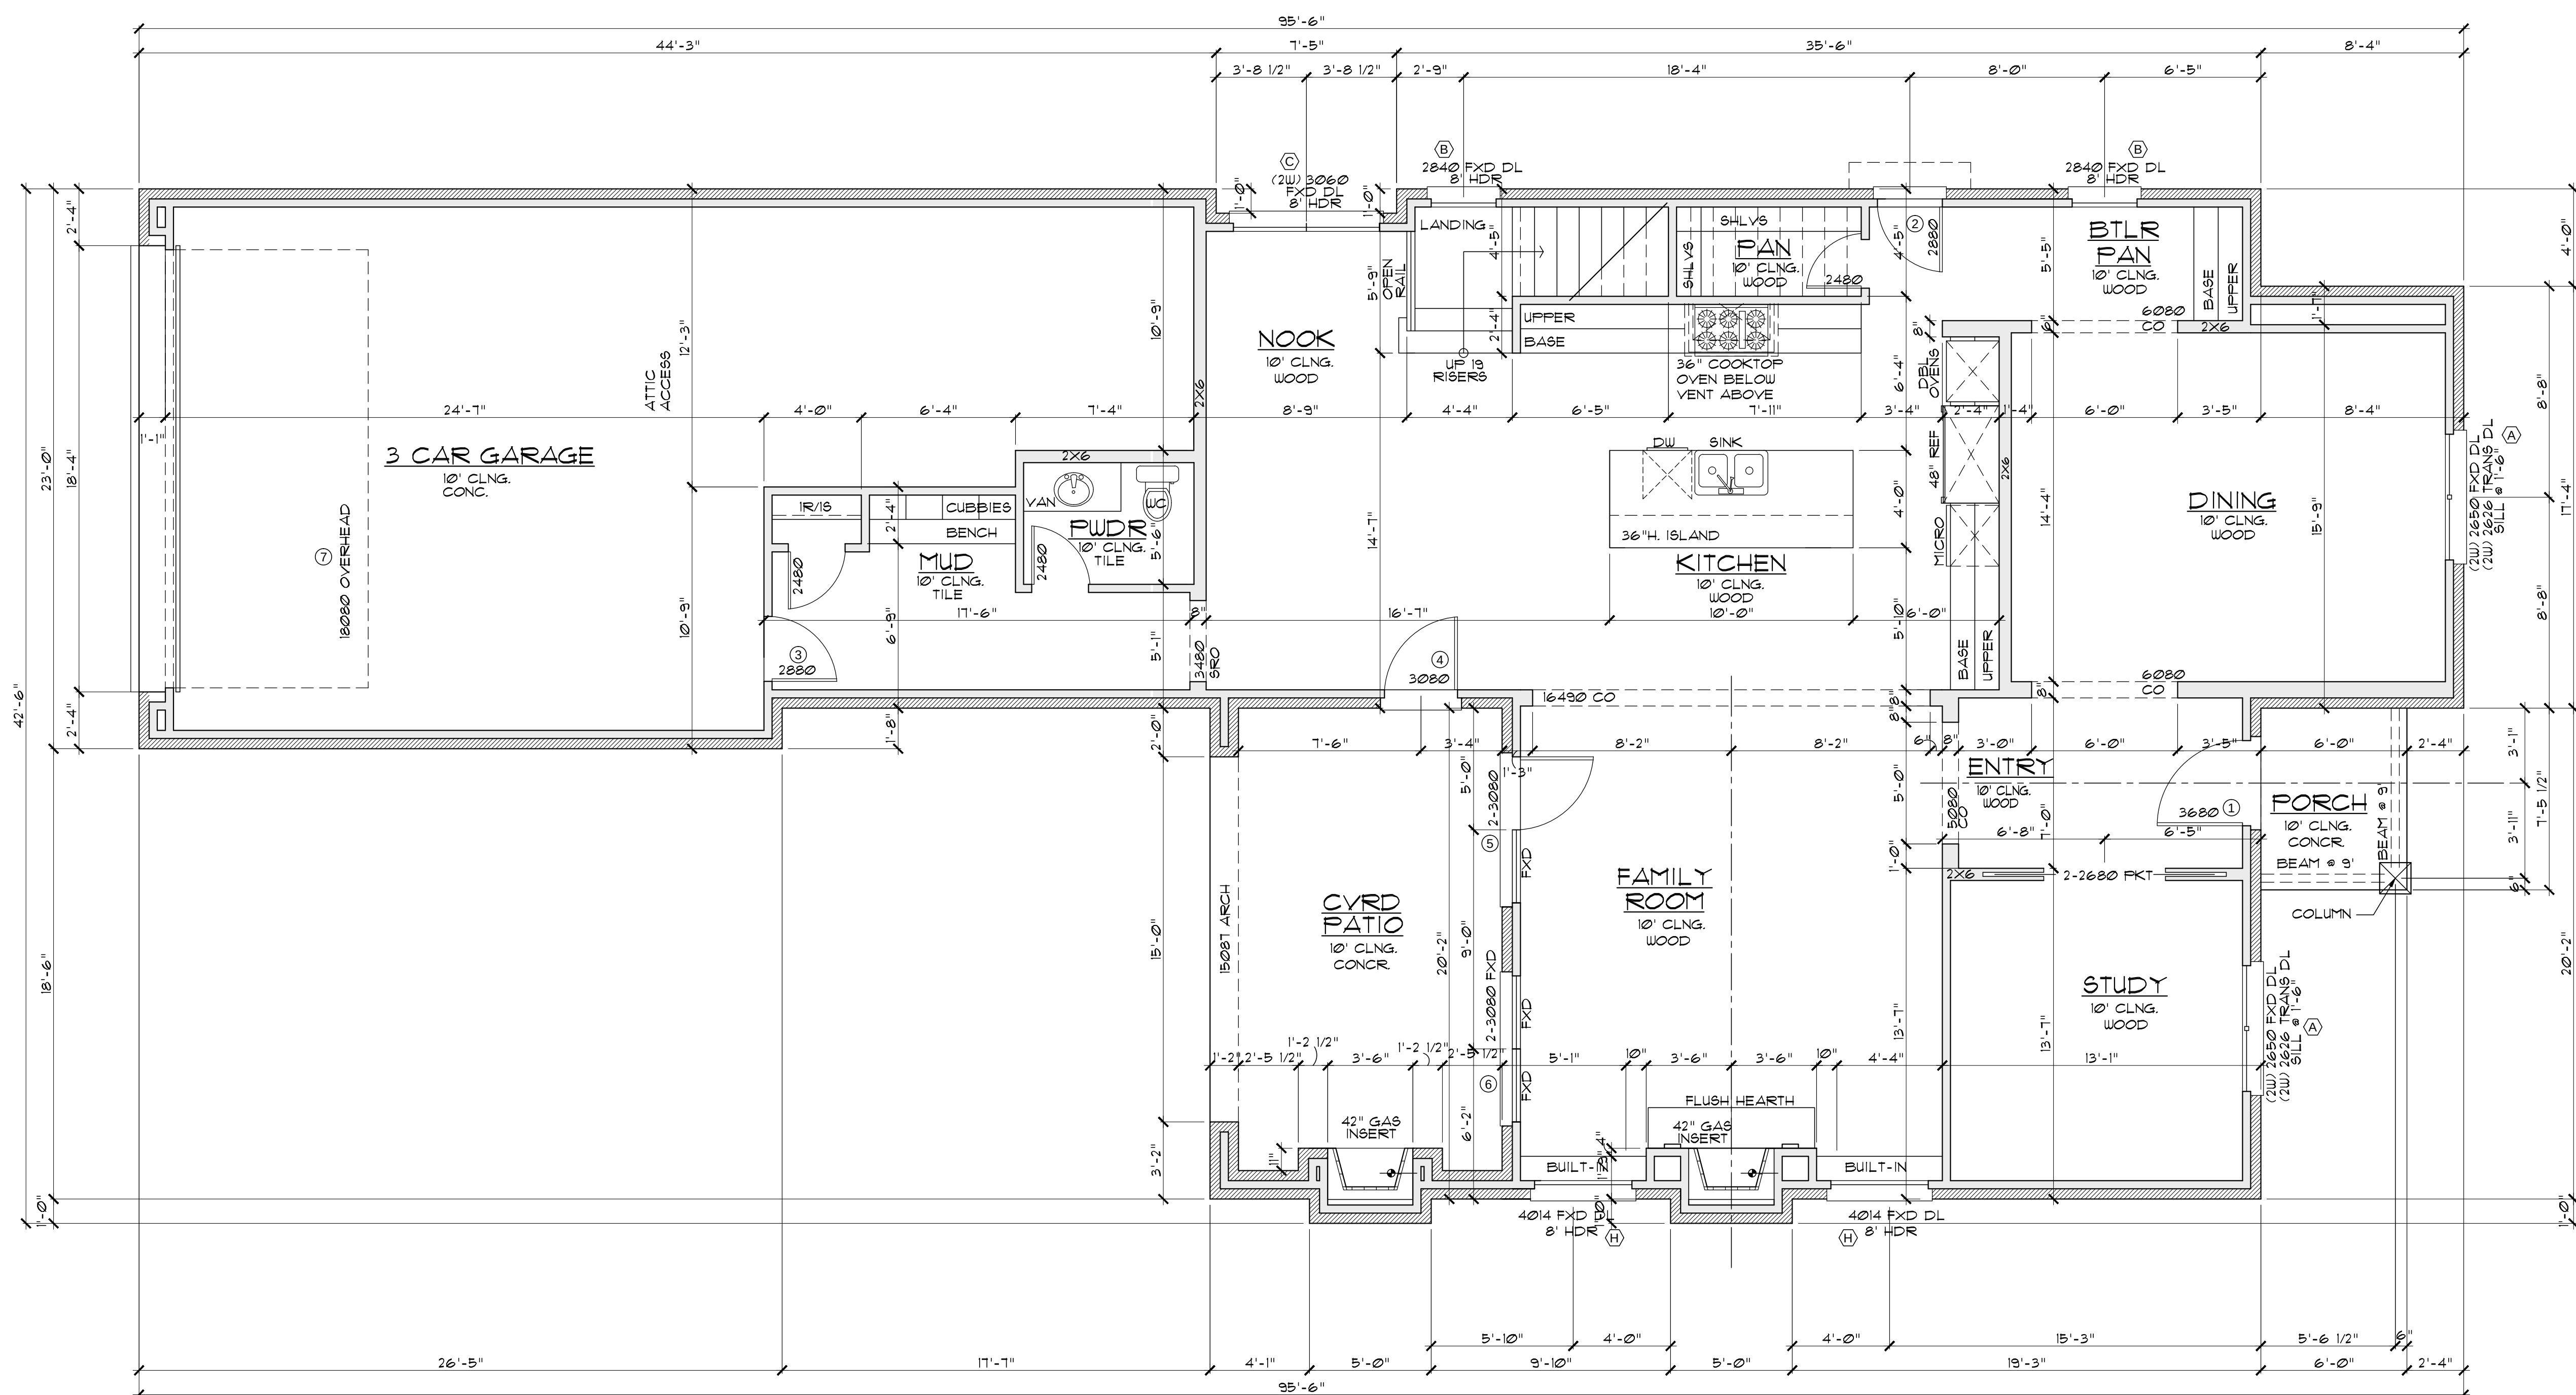

① FIRST FLOOR PLAN
SCALE: 1/4"=1'-0"

AREA TABULATION:	
FIRST FLOOR A/C:	1870 sq.ft.
SECOND FLOOR A/C:	1913 sq.ft.
TOTAL A/C:	3783 sq.ft.
GARAGE:	797 sq.ft.
FRONT PORCH	44 sq.ft.
REAR PORCH	246 sq.ft.
TOTAL SLAB AREA:	2957 sq.ft.
TOTAL AREA UNDER ROOF:	4870 sq.ft.

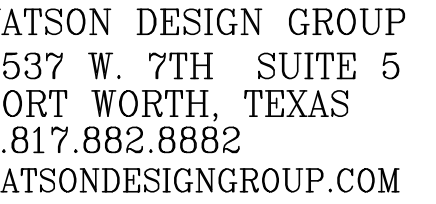


Copyright, S. Watson Design, Inc. – 2016

7503 CAILET STREET
LOT 9 BLOCK 9/4840
LOVERS LANE HEIGHTS
AN ADDITION TO THE CITY OF
DALLAS, DALLAS COUNTY, TX

PLAN NUMBER
9378316

DATE
9/2/2016

SHEET NUMBER
A3

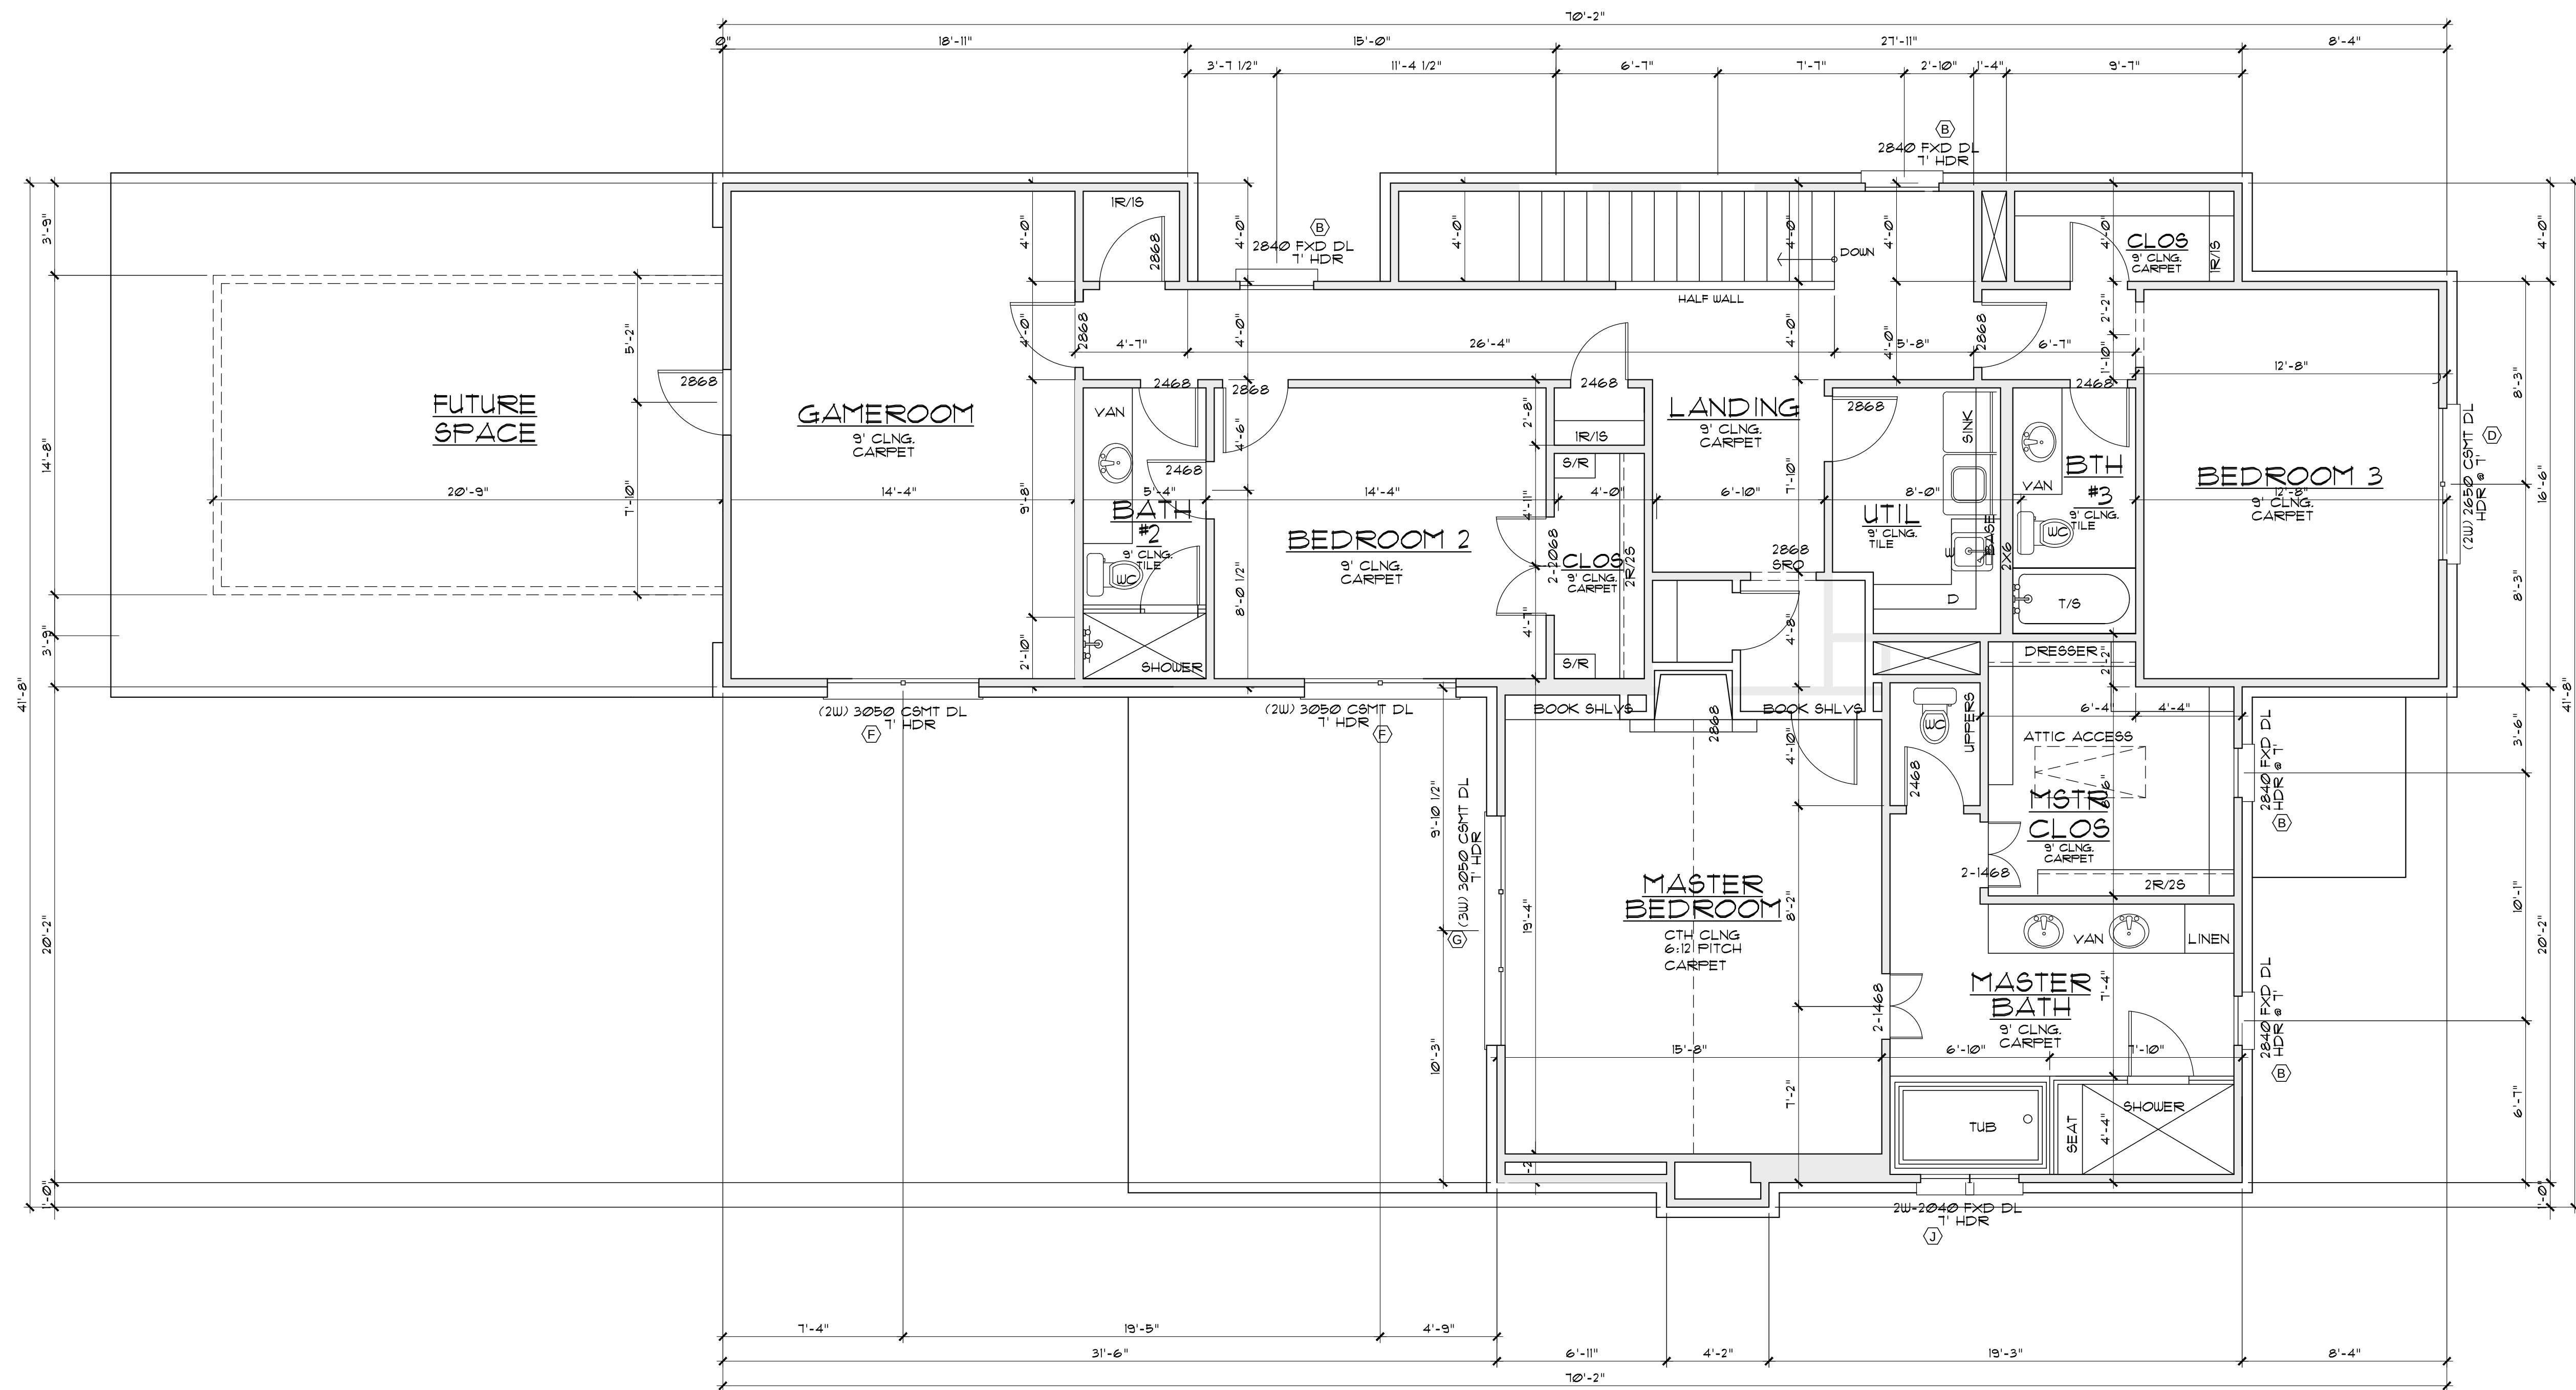

1 SECOND FLOOR PLAN
SCALE: 1/4" = 1'-0"




Copyright, S. Watson Design, Inc. — 2016

7503 CAILET STREET
LOT 9 BLOCK 9/4840
LOVERS LANE HEIGHTS
AN ADDITION TO THE CITY OF
DALLAS, DALLAS COUNTY, TX

PLAN NUMBER
9378316

DATE
9/2/2016

SHEET NUMBER
A4

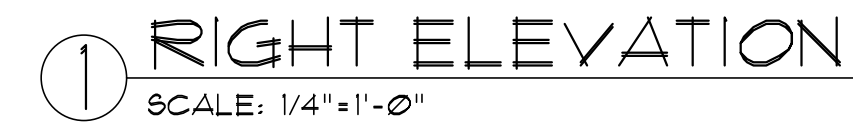




Copyright, S. Watson Design, Inc. — 2016

7503 CAILET STREET
LOT 9 BLOCK 9/4840
LOVERS LANE HEIGHTS
AN ADDITION TO THE CITY OF
DALLAS, DALLAS COUNTY, TX

PLAN NUMBER
9378316

DATE
9/2/2016

SHEET NUMBER
A5

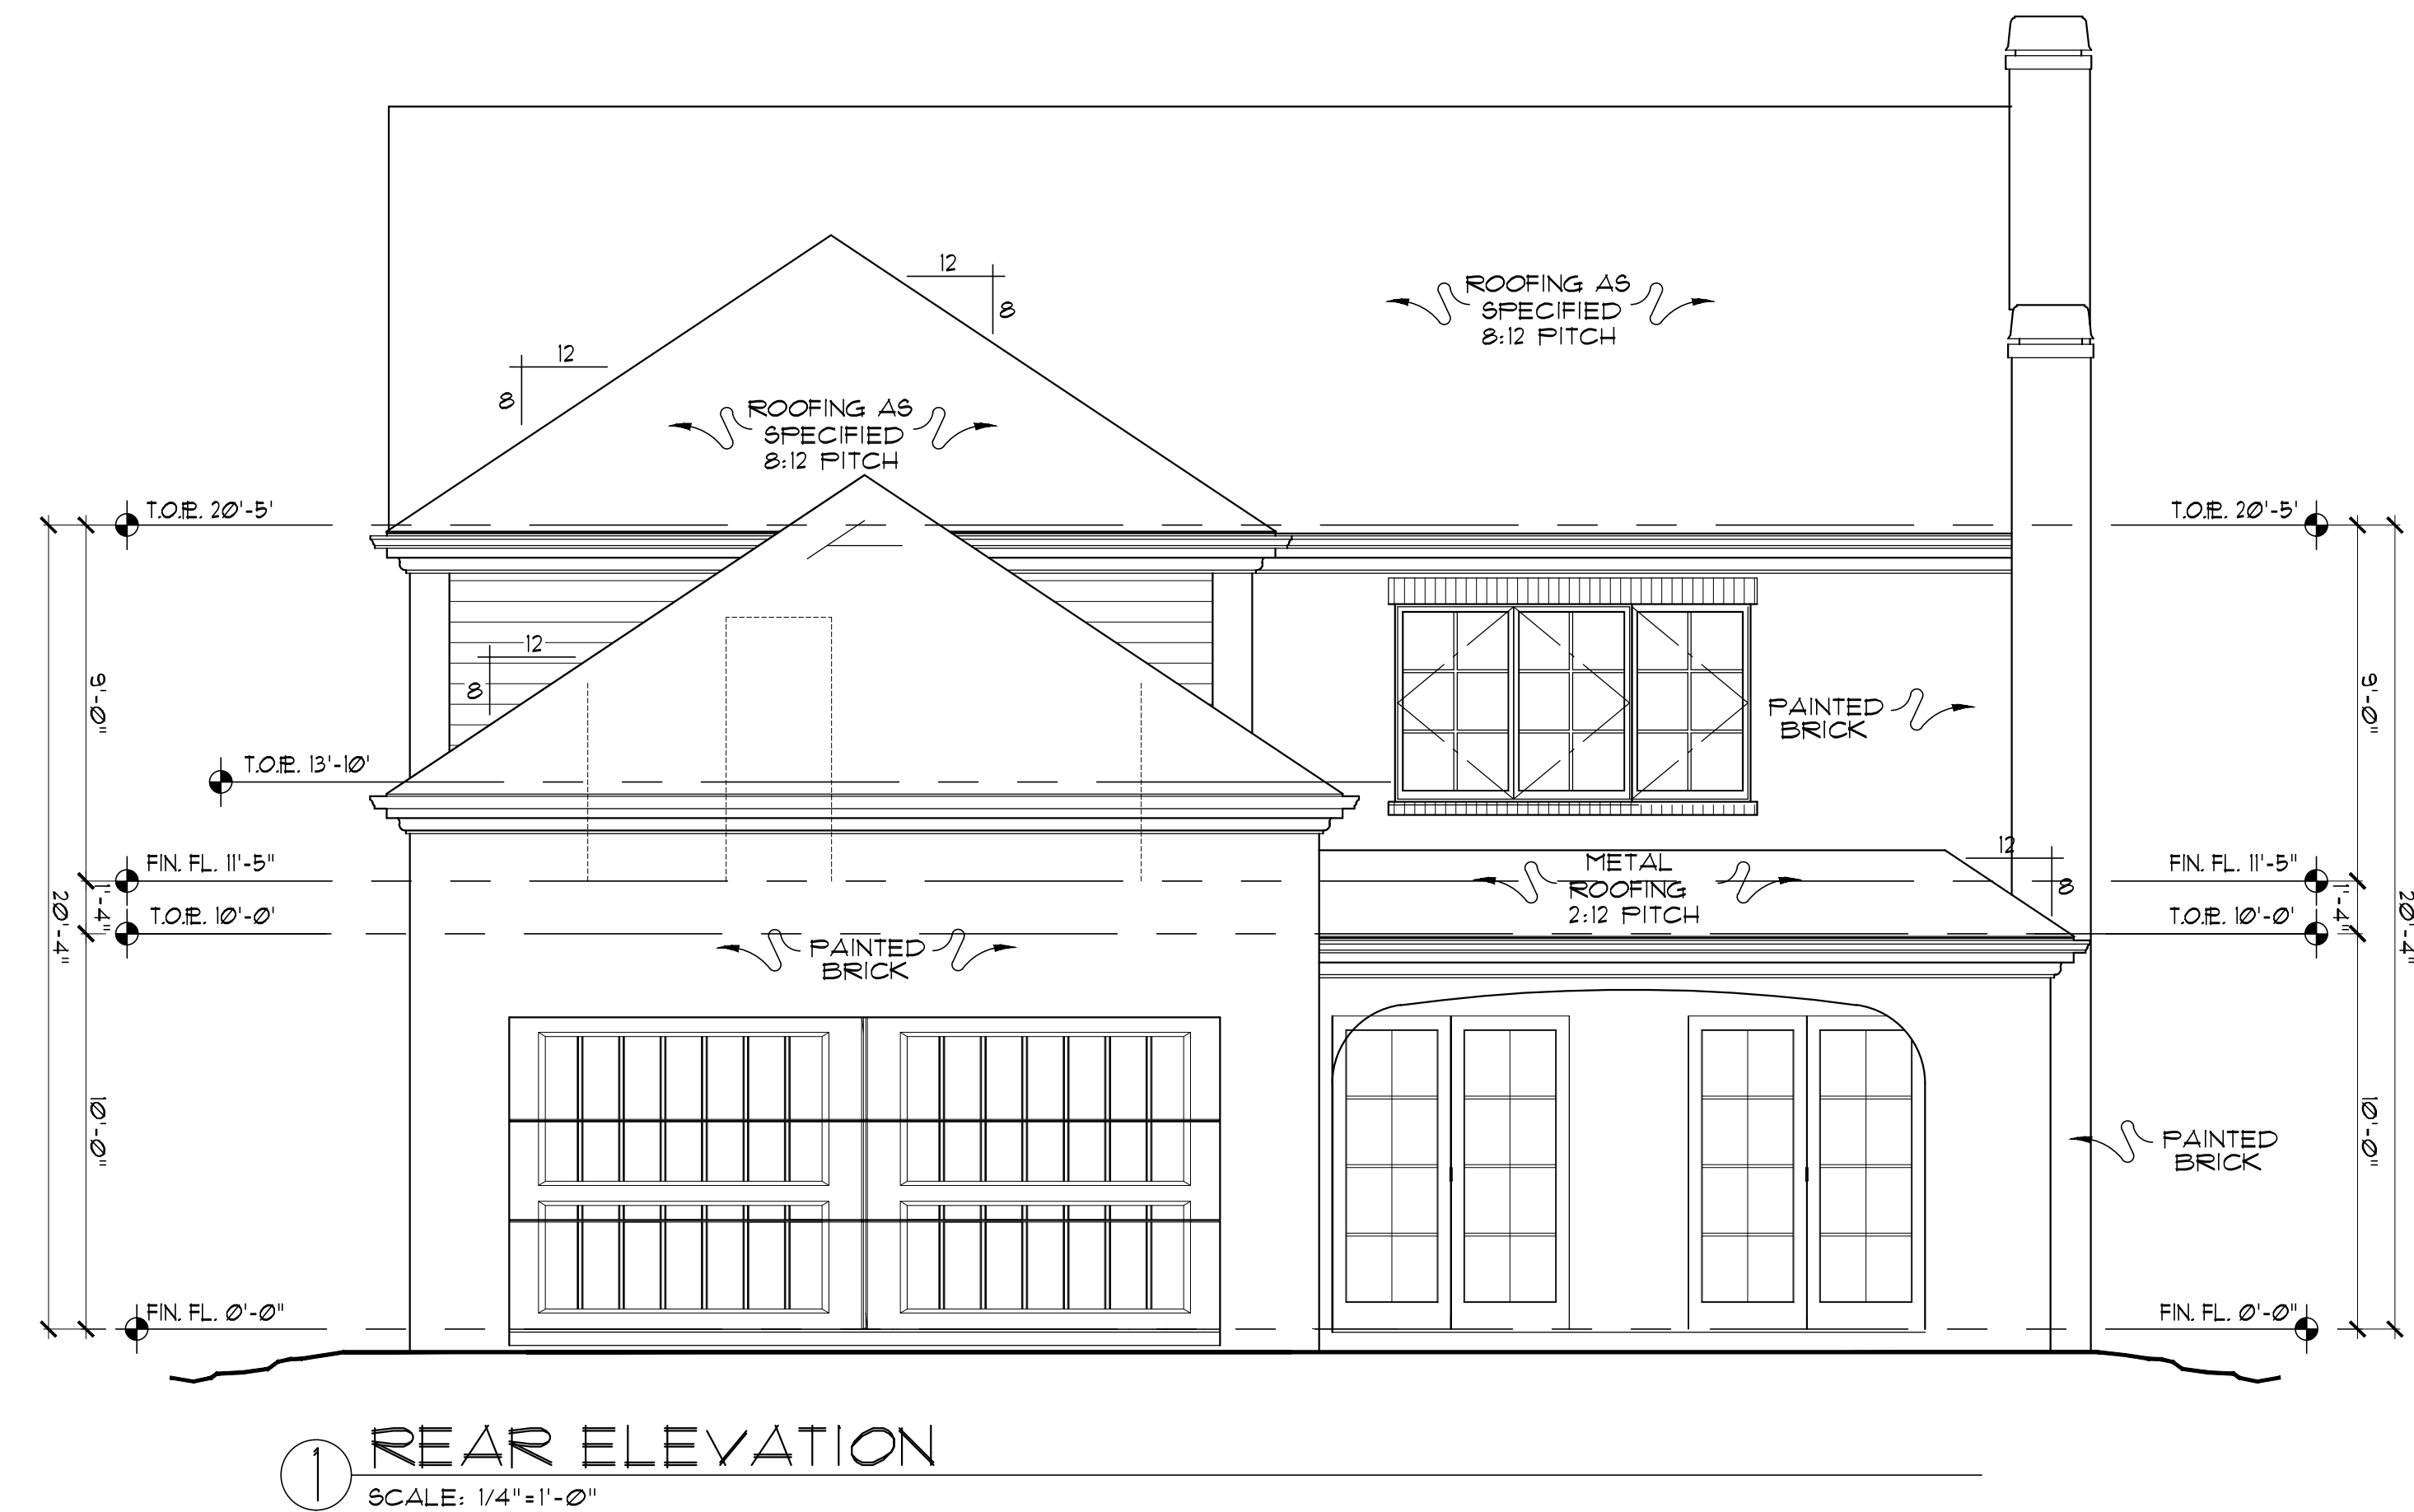


Copyright, S. Watson Design, Inc. – 2016


OLERIO HOMES
7503 CAILLET STREET
LOT 9 BLOCK 9/4840
LOVERS LANE HEIGHTS
AN ADDITION TO THE CITY OF
DALLAS, DALLAS COUNTY, TX

PLAN NUMBER
9378316

DATE
9/2/2016




SHEET NUMBER
A6

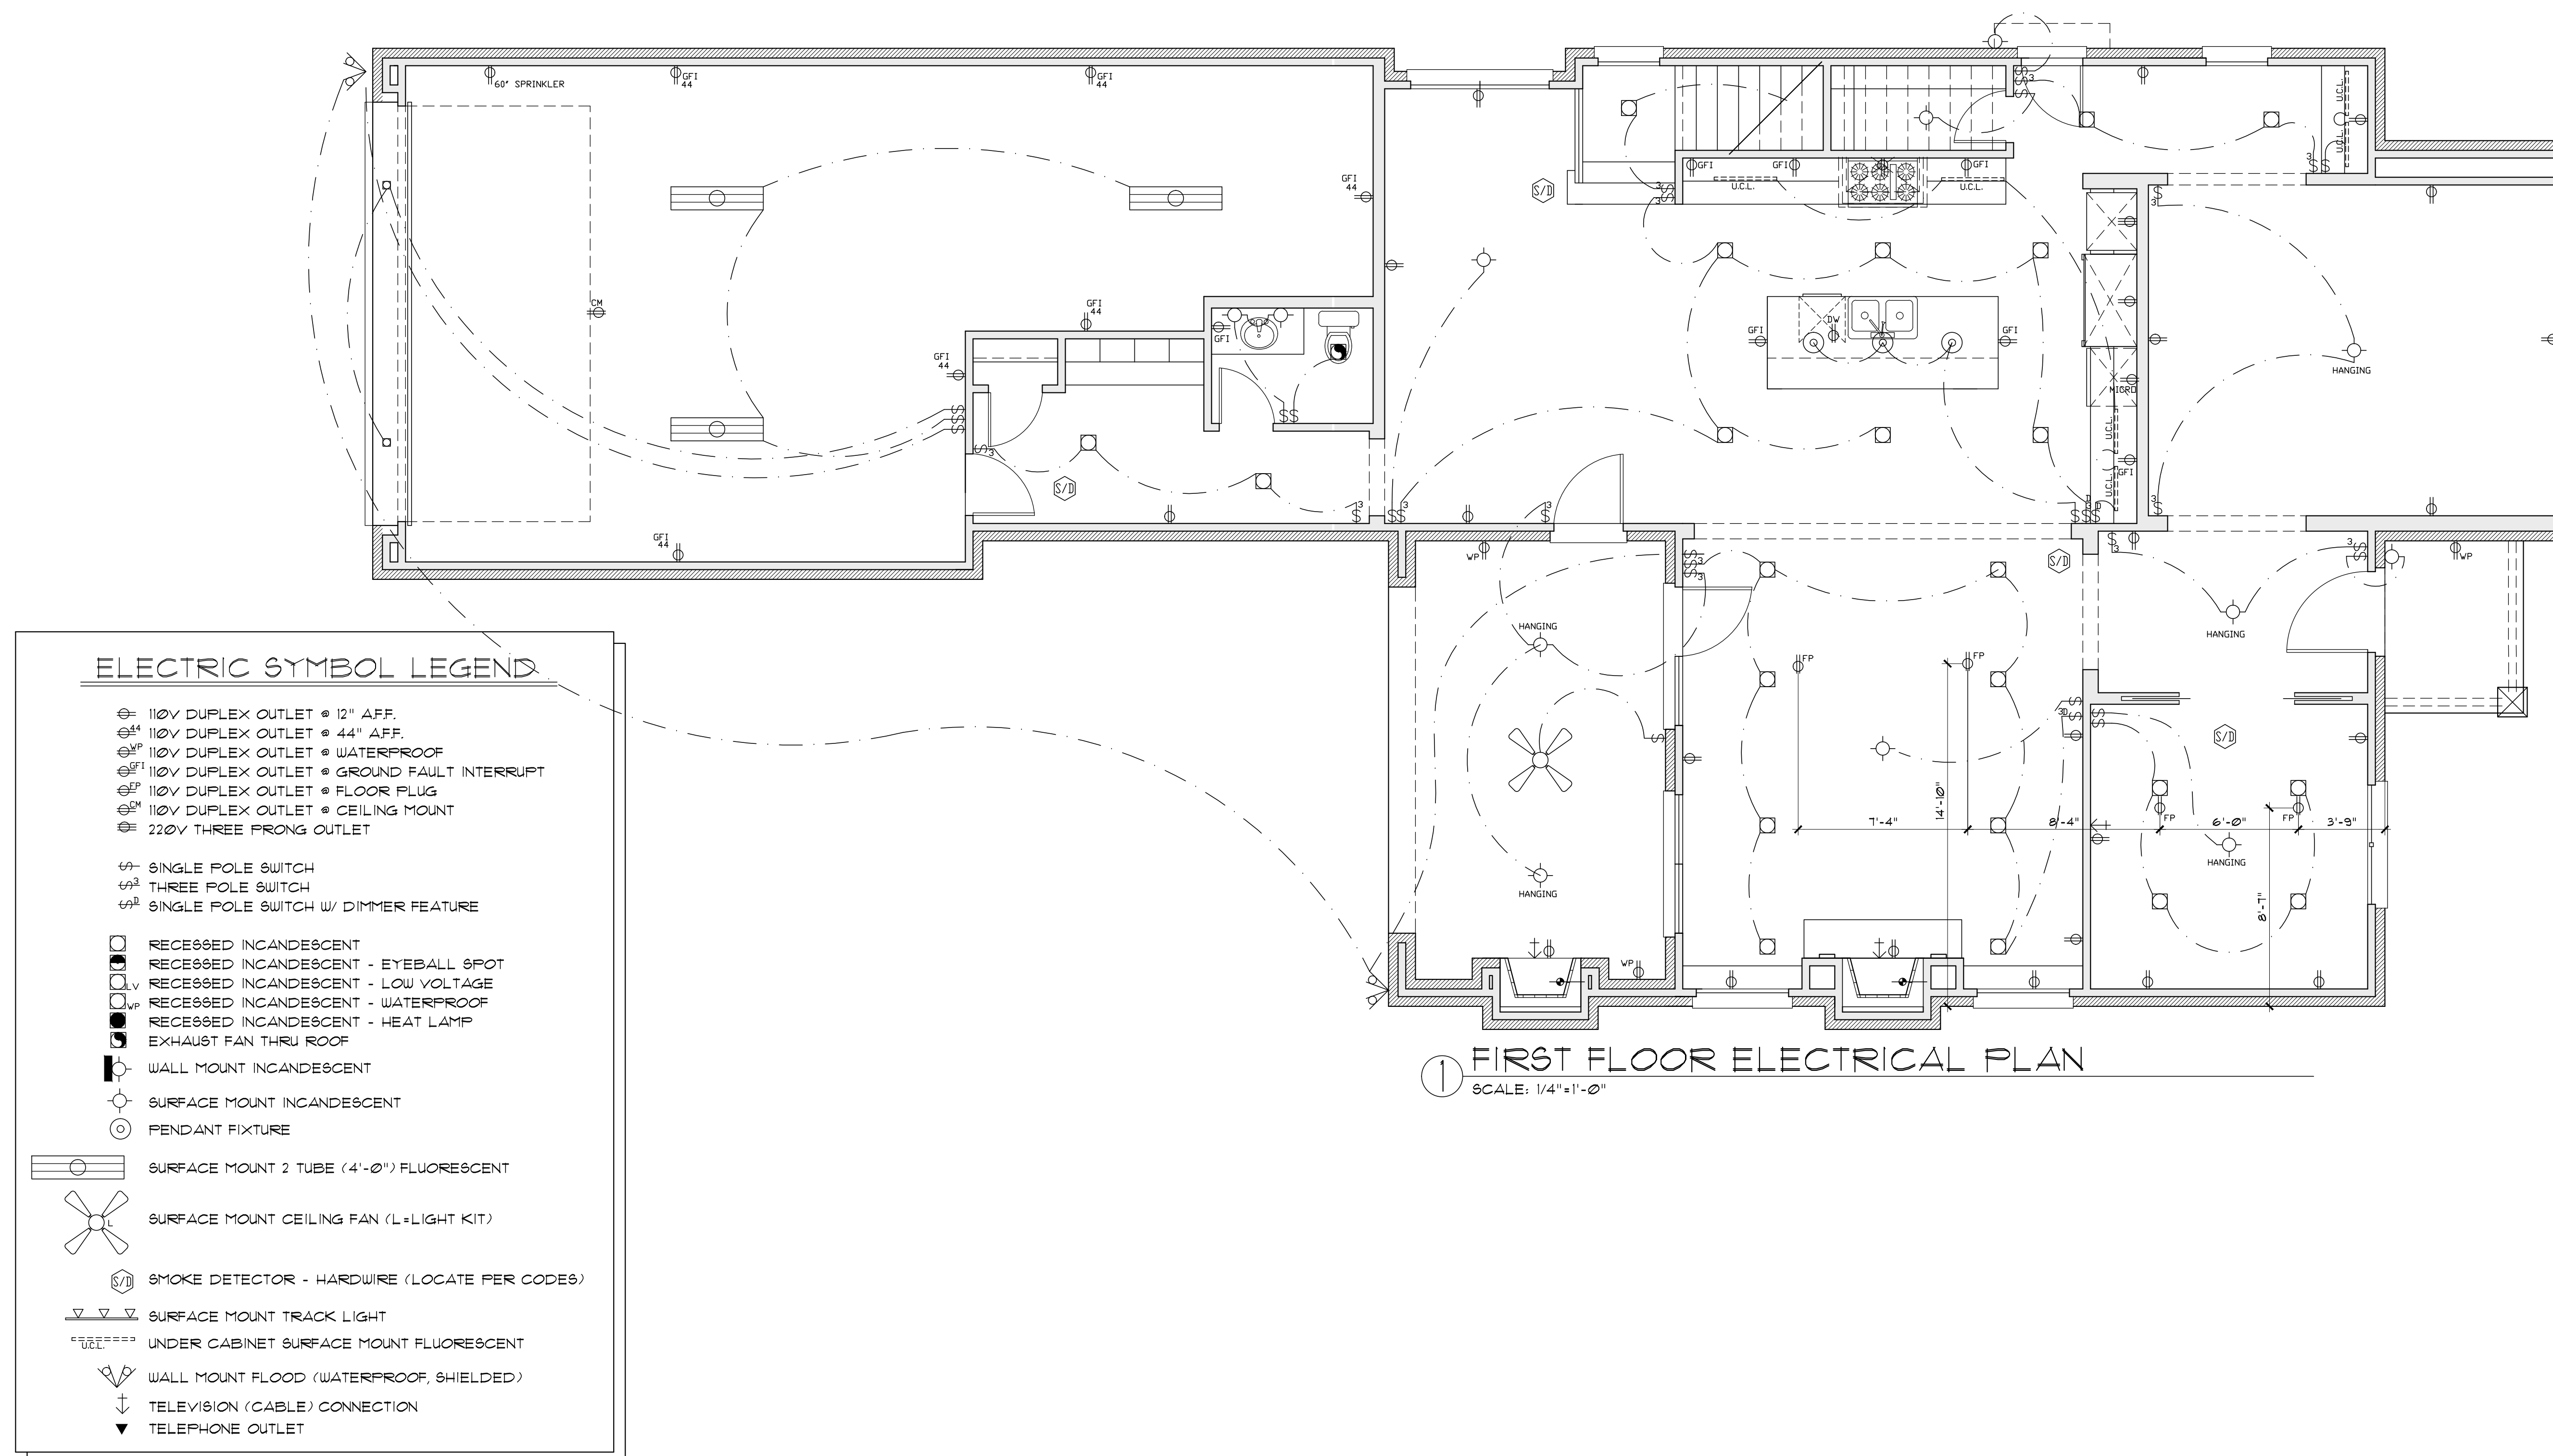

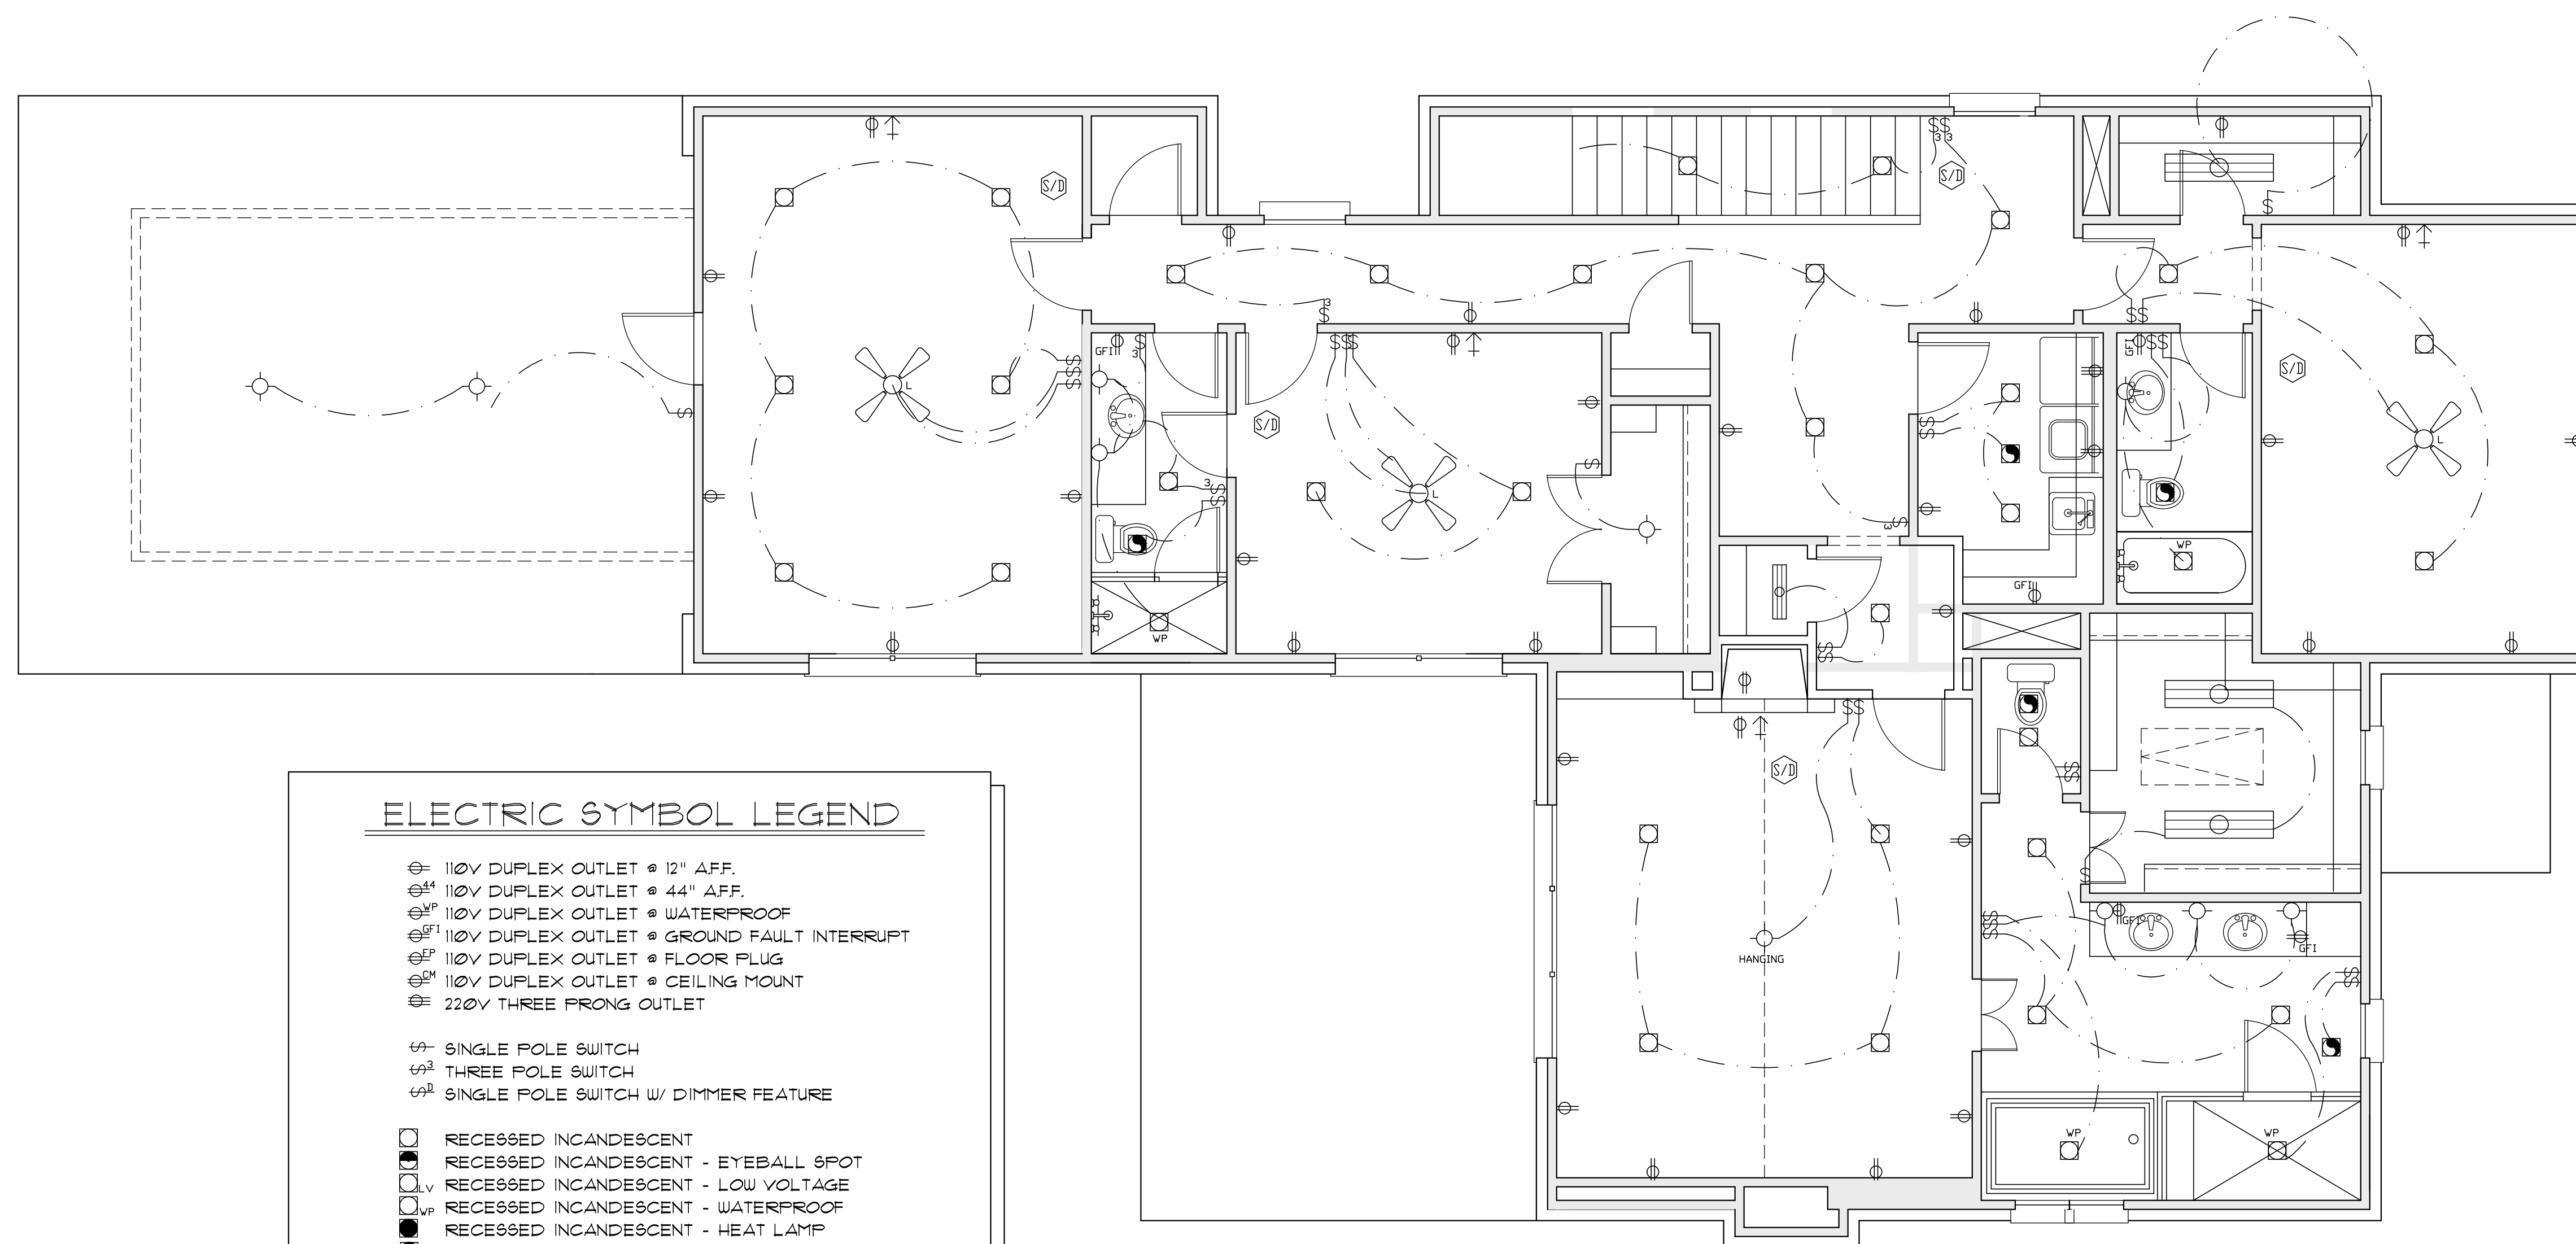

① SECOND FLOOR ELECTRICAL PLAN
SCALE: 1/4"=1'-0"

  ELECTRIC SYMBOL LEGEND

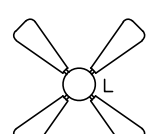	110V DUPLEX OUTLET @ 12" AFF.
	110V DUPLEX OUTLET @ 44" AFF.
	110V DUPLEX OUTLET @ WATERPROOF
	110V DUPLEX OUTLET @ GROUND FAULT INTERRUPT
	110V DUPLEX OUTLET @ FLOOR PLUG
	110V DUPLEX OUTLET @ CEILING MOUNT
	220V THREE PRONG OUTLET
	SINGLE POLE SWITCH
	THREE POLE SWITCH
	SINGLE POLE SWITCH W/ DIMMER FEATURE
	RECESSED INCANDESCENT
	RECESSED INCANDESCENT - EYEBALL SPOT
	RECESSED INCANDESCENT - LOW VOLTAGE
	RECESSED INCANDESCENT - WATERPROOF
	RECESSED INCANDESCENT - HEAT LAMP
	EXHAUST FAN THRU ROOF
	WALL MOUNT INCANDESCENT
	SURFACE MOUNT INCANDESCENT
	PENDANT FIXTURE
	SURFACE MOUNT 2 TUBE (4'-0") FLUORESCENT
	SURFACE MOUNT CEILING FAN (L=LIGHT KIT)
	SMOKE DETECTOR - HARDWARE (LOCATE PER CODES)
	SURFACE MOUNT TRACK LIGHT
	UNDER CABINET SURFACE MOUNT FLUORESCENT
	WALL MOUNT FLOOD (WATERPROOF, SHIELDED)
	TELEVISION (CABLE) CONNECTION
	TELEPHONE OUTLET