



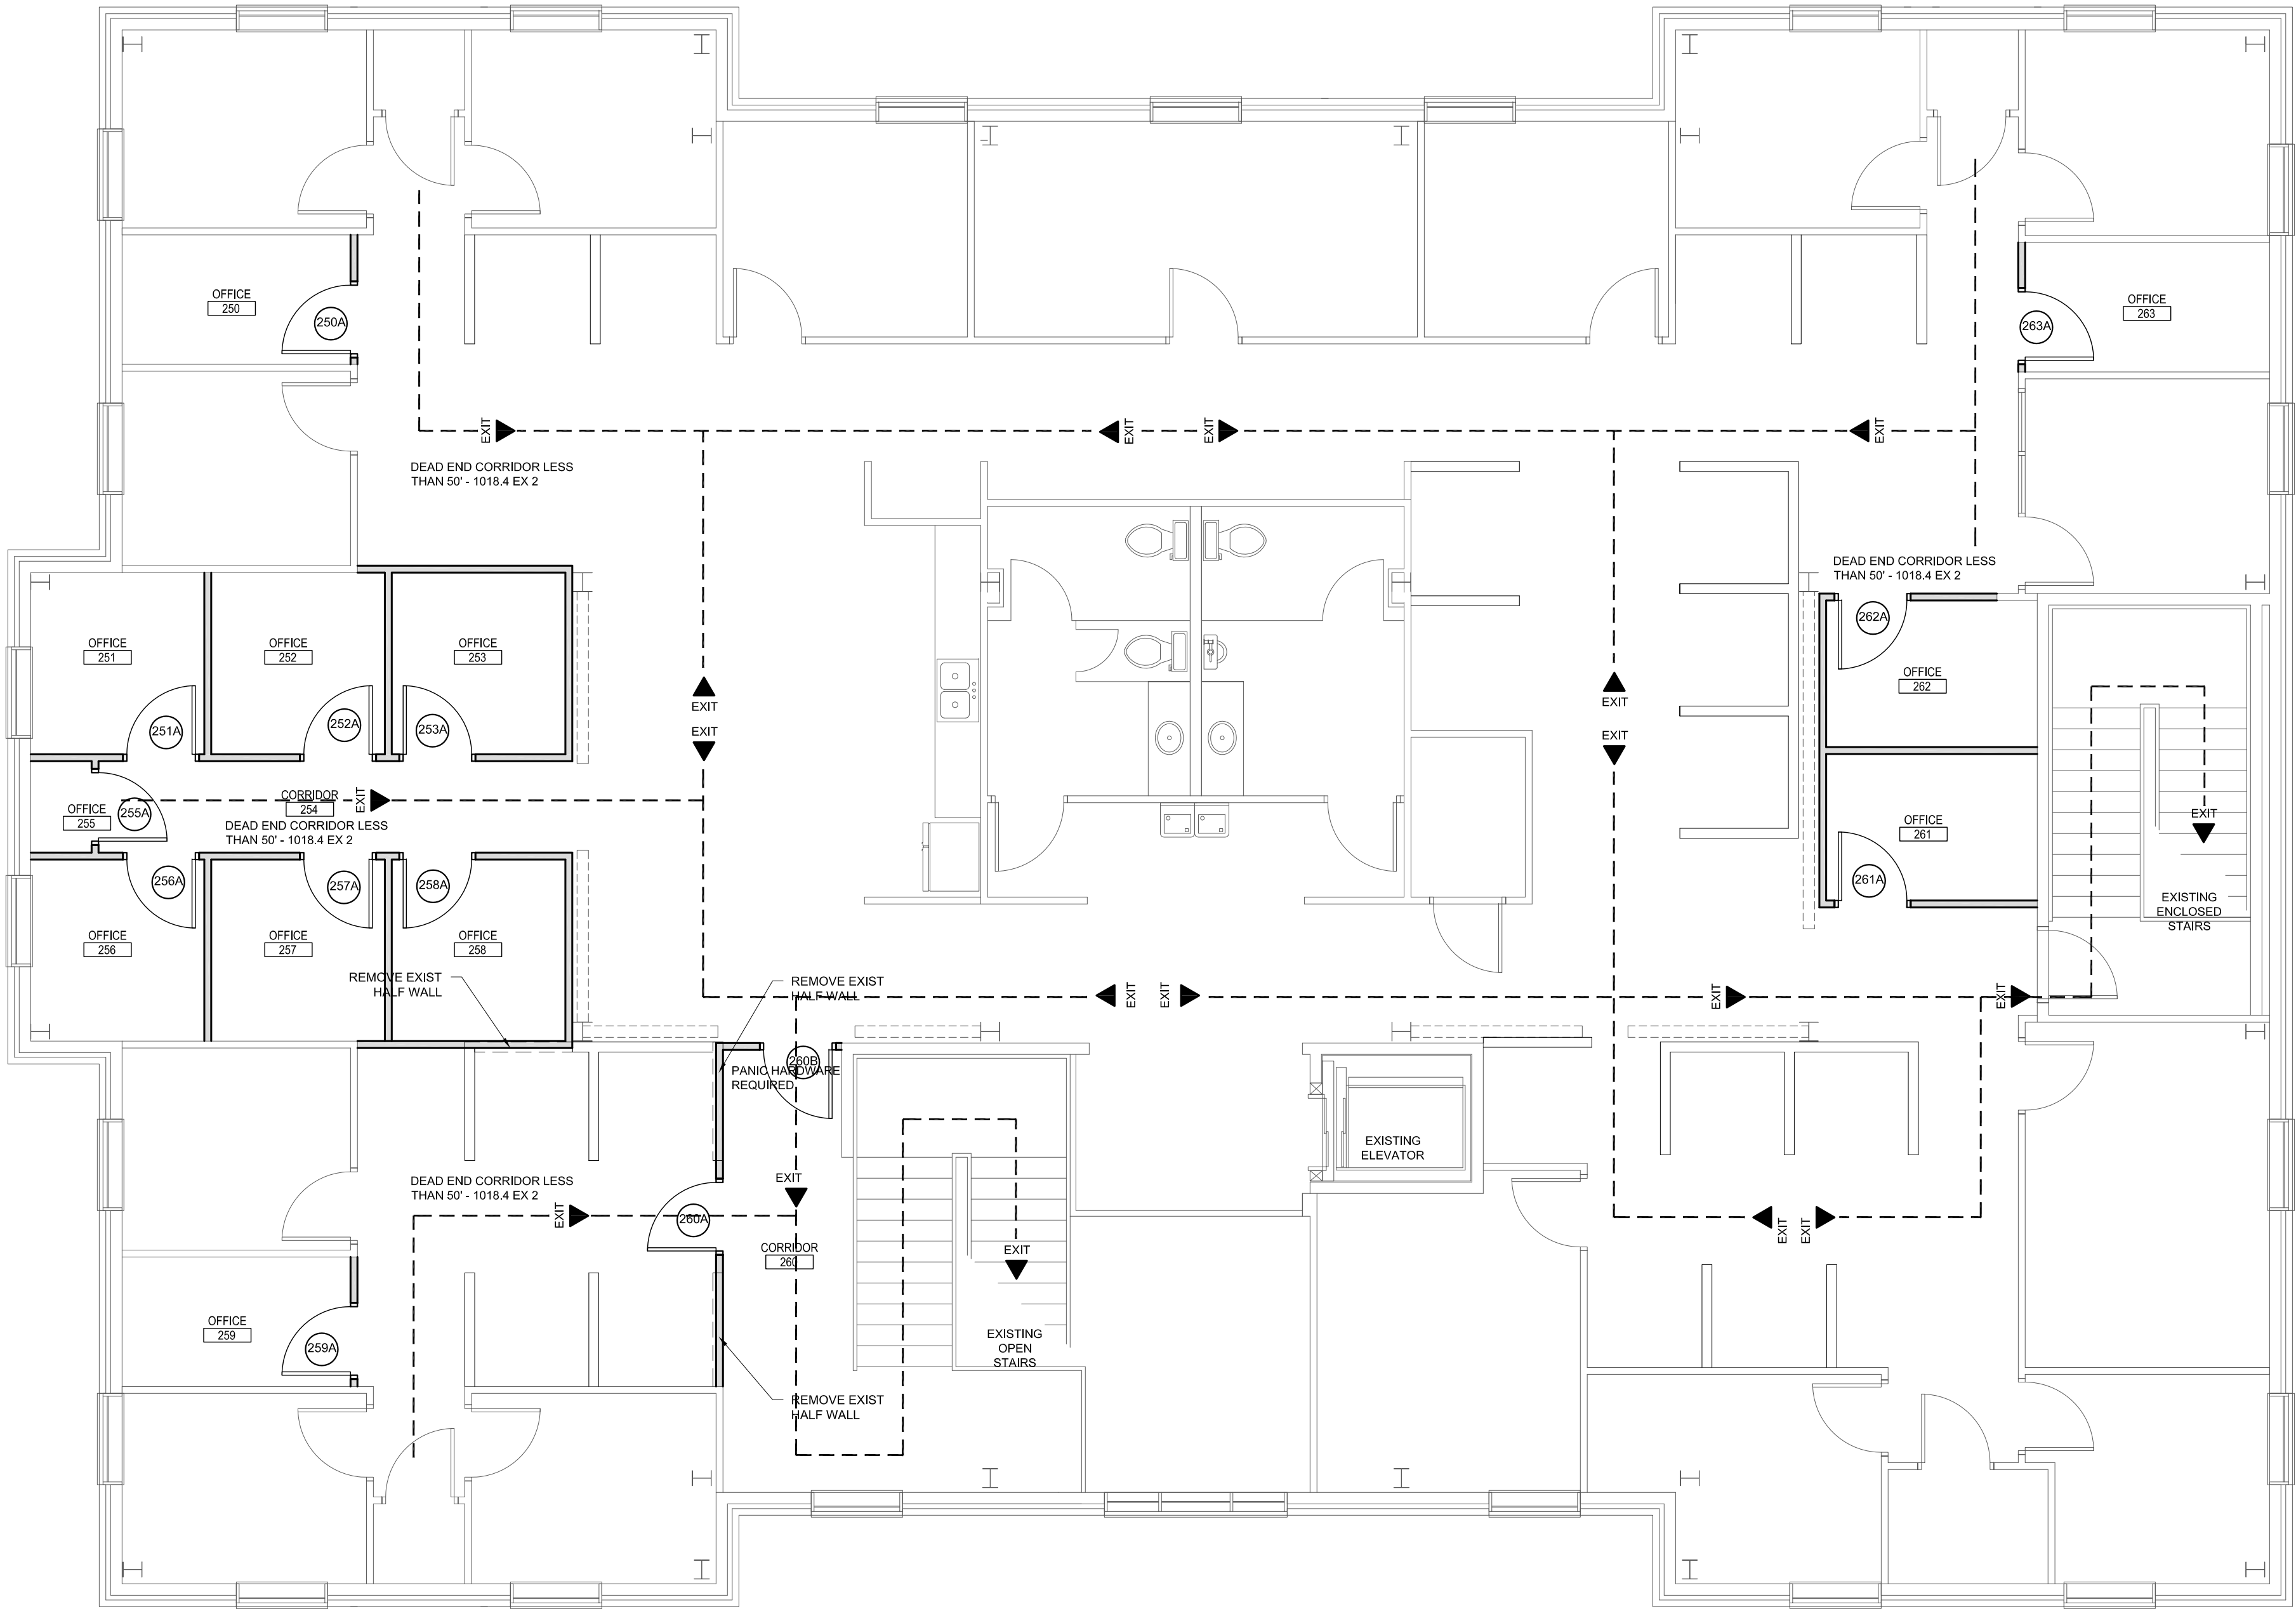

SEE ELECTRICAL PLANS FOR
EMERGENCY LIGHTS AND EXIT SIGNS
LEVEL TWO PLAN
SCALE : 3/32" = 1'-0"

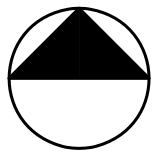

APPLICABLE CODES

CODE	DESCRIPTION	COMPRISED OF
GENERAL ADMINISTRATION RULES	GENERAL ADMINISTRATION RULES (GAR) (UPDATED 8.1.2014) (AMENDED 12.1.2014)	675 IAC 12
BUILDING CODE (INDIANA AMENDMENTS)	2014 INDIANA BUILDING CODE (675 IAC 13-2.6) EFFECTIVE DECEMBER 1, 2014	2012 INTERNATIONAL BUILDING CODE 675 IAC 13-2.6
FIRE CODE (INDIANA AMENDMENTS)	2014 INDIANA FIRE CODE (IFC) EFFECTIVE DECEMBER 1, 2014	2012 INTERNATIONAL FIRE CODE 675 IAC 22-2.5
PLUMBING CODE (INDIANA AMENDMENTS)	2012 INDIANA PLUMBING CODE (IPC) EFFECTIVE DECEMBER 24, 2012	2006 INTERNATIONAL PLUMBING CODE 675 IAC 16-1.4
ELECTRICAL CODE (INDIANA AMENDMENTS)	2009 INDIANA ELECTRICAL CODE (IEC) EFFECTIVE AUGUST 26, 2009	2008 NFPA 70 675 IAC 17-1.8
MECHANICAL CODE (INDIANA AMENDMENTS)	2014 INDIANA MECHANICAL CODE (675 IAC 18-1.6) EFFECTIVE DECEMBER 1, 2014	2012 INTERNATIONAL MECHANICAL CODE 675 IAC 18-1.6
HANDICAPPED ACCESSIBILITY CODE (INDIANA AMENDMENTS)	2008 INDIANA BUILDING CODE CHAPTER 11 - ACCESSIBILITY	675 IAC 13-2.5-12 CHAPTER 11
ENERGY CODE (INDIANA AMENDMENTS)	2010 INDIANA ENERGY CONSERVATION CODE (IECC) EFFECTIVE MAY 7, 2010	ASHRAE STANDARD 90.1, 2007 675 IAC 19-4
ELEVATOR SAFETY CODE	2011 INDIANA ELEVATOR SAFETY CODE (IESC) (UPDATED 9-28-11)	675 IAC 21 - ANSI / ASMEA17.1, 2007 ANSI / ASME A90.1, 2003 ANSI / A10.4, 2004 ASME / A18.1, 2005
BUILDING REHABILITATION STANDARD (INDIANA AMENDMENTS)	INDIANA BUILDING REHABILITATION STANDARD (GAR) (UPDATED 12.22.08) (REPEALED JUNE 18, 2008)	675 IAC 12-8
SANITARY CODE (INDIANA AMENDMENTS)	1998 AMERICAN SOCIETY OF SANITARY ENGINEERS STANDARD 1051	675 IAC 16-2

CODE ANALYSIS


EXISTING BUILDING AREA	19,096 SQ. FT. (27,000 ALLOWABLE - 9,000 PER FLOOR)
EXISTING BASEMENT	6,328 SQ. FT.
EXISTING LEVEL ONE	6,520 SQ. FT.
EXISTING LEVEL TWO	6,238 SQ. FT.
AREA OF LEVEL TWO REMODEL	6,238 SQ. FT.
BUILDING HEIGHT / NO. OF FLOORS	3 STORIES - (504.2)
EXISTING OCCUPANCY	B
PROPOSED OCCUPANCY	B
TABULAR OCCUPANT LOAD (1004.1.1)	63 (6238 / 100 SQ FT / PERSON - LEVEL TWO REMODEL)
EXISTING CONSTRUCTION TYPE	V B
PROPOSED CONSTRUCTION TYPE	V B
FIRE SUPPRESSION SYSTEM	FULL
EXITS REQUIRED	2
FIRE RATED STORAGE ROOMS	NONE OVER 100 SQ FT
FIRE RATED CORRIDORS	NONE (TABLE 1017.1)
SEPARATION WALLS REQUIRED	NONE

- NOTES:
- ALLOWABLE AREAS AND CONSTRUCTION TYPES PER TABLE 503
 - COMBUSTIBLE MATERIALS ARE ALLOWED PER SECTION 603.1
 - DRAFT STOPPING IS NOT REQUIRED - 717.3.3 - EXCEPTION FOR SPRINKLED BUILDINGS
 - MINIMUM EGRESS WIDTHS AND ILLUMINATION ARE PROVIDE PER SECTION 1005 / 1006
 - AN ACCESSIBLE MEANS OF EGRESS HAS BEEN PROVIDED PER SECTION 1007 -INCLUDING STAIR WIDTHS
 - ALL DOORS IN AREAS SERVING AN OCCUPANT LOAD GREATER THAN 50 SWING IN THE DIRECTION OF TRAVEL
 - ALL STAIRS MEET THE REQUIREMENTS OF SECTION 1009 AND HAVE SOLID RISERS
 - THE COMMON PATH OF EGRESS DOES NOT EXCEED 100' (SPRINKLED BUILDING)
 - ALL EXITS MEET THE TRAVEL DISTANCE REQUIREMENTS OF TABLE 1016.1
 - THERE ARE NO DEAD END CORRIDORS IN EXCESS OF 50' - 1017.3, EX. 2
 - STAIR ENCLOSURES WHERE REQUIRED HAVE BEEN PROVIDED
 - 1015.2.1 - OVERALL DIAGONAL - 116' - DISTANCE BETWEEN EXITS - 51' (GREATER THAN 1/3 THE DIAGONAL DISTANCE)



PHASE I LEVEL TWO RENOVATION
BLOOMERANG
5724 BIRTZ RD
LAWRENCE, INDIANA 46216
PERMIT SET 12_22_16

STUART R SHADE RA
13245 ALLISONVILLE RD
FISHERS, INDIANA 46038
PHONE: 317-989-6248
E-MAIL : stushade@att.net

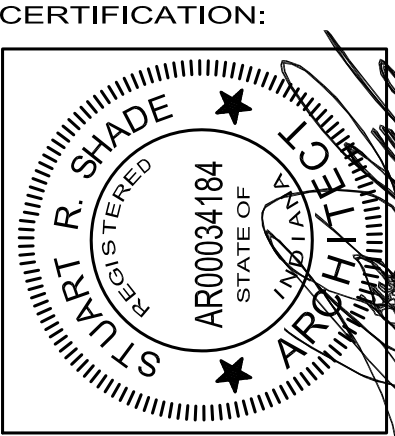

ALL IDEAS, DESIGNS AND PLANS INDICATED OR REPRESENTED BY THESE DRAWINGS ARE OWNED BY, AND THE PROPERTY OF STUART R SHADE, RA. CONTRACTORS SHALL VERIFY AND BE RESPONSIBLE FOR ALL DIMENSIONS ON THE JOB SITE. ALL RIGHTS RESERVED, EXCEPT FOR USES EXPRESSLY PERMITTED IN WRITING.
DATE: 22 DECEMBER, 2016
REV 1 :
REV 2 :
SHEET NUMBER: