


6/4/2019 1:46:31 PM

D

C

B

A

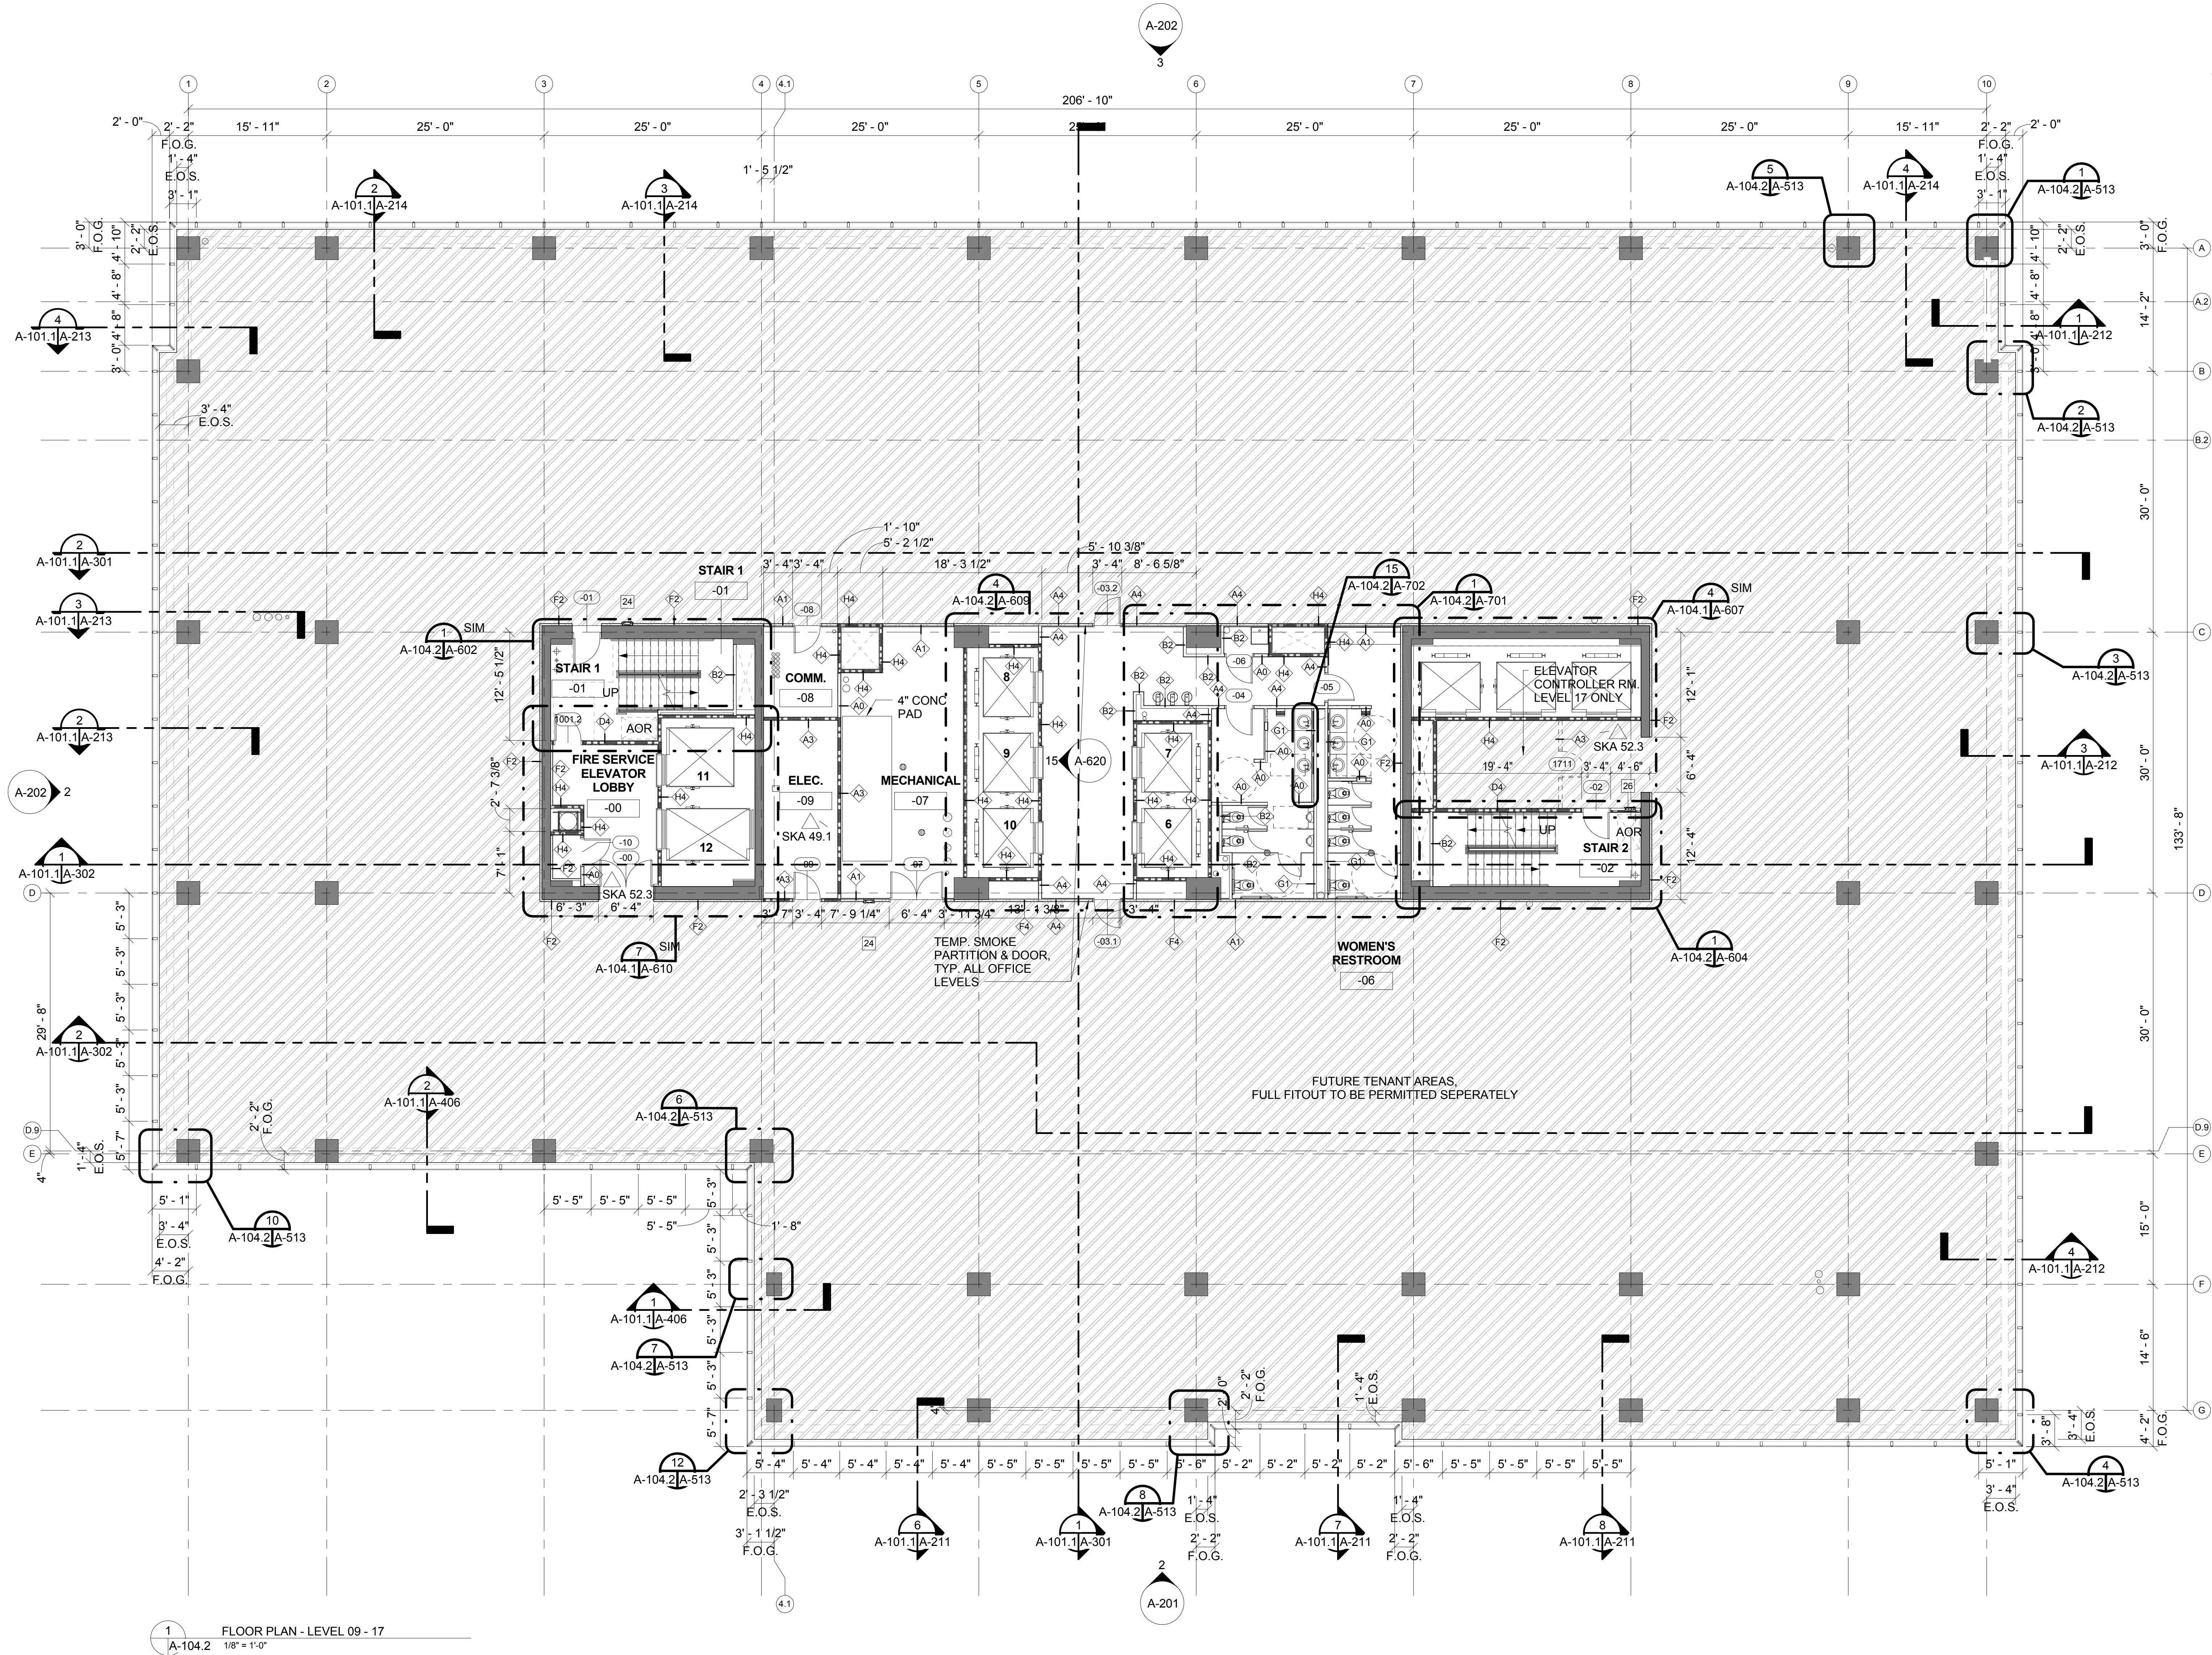

KEYNOTES
26 SEMI RECESSED FIRE
RATED FIRE
EXTINGUISHER CABINET



Mirecourt
Associates, LLC

URS | AECOM

2020 K ST. NW, STE 300
WASHINGTON, DC 20006

SEALS

PROFESSIONAL CERTIFICATION I CERTIFY THAT THESE
DOCUMENTS WERE PREPARED OR APPROVED BY ME, AND
THAT I AM A DULY LICENSED PROFESSIONAL ARCHITECT
UNDER THE LAWS OF THE STATE OF MARYLAND.
LICENSE NUMBER 16789
EXPIRATION DATE 10-05-2020.

One Light Street
Baltimore, Maryland

PROJECT ISSUE DATES	
DATE	DESCRIPTION
06/20/2017	HOIST AFFECTED AREA EXHIBIT
01/23/2018	SKA 49.1 - ELEC. RM REVISION
02/01/2018	SKA 52.3
06/08/2018	BULLETIN #2 - CONFORMED SET
05/31/2019	RECORD DRAWINGS

DRAWN BY
WDC
CHECKED BY
DM
DESIGNED BY
GB

FLOOR PLAN -
LEVEL 09-17 - TYP
OFFICE

A-104.2

Copyright © 2009 URS Corporation. All Rights Reserved