




100 north sixth street  
suite 650c  
minneapolis, mn  
55403-1594

T 612 339 2257  
F 612 349 2930

www.shealink.com



UNILEV MANAGEMENT CORP

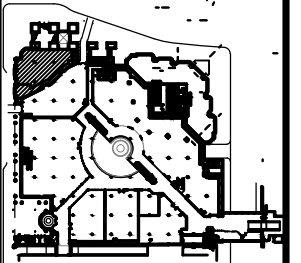

KEY PLAN  
**AS-BUILT  
FLOOR PLAN  
FLOOR 2  
SUITE #201  
WELLS FARGO  
RIVE THRU  
5,986 USF  
6,944 RSF**

comm. no.: 6370.01


scale: NOT TO SCALE

date: 3.30.11

revision date:

drawn by:

**AB-201**

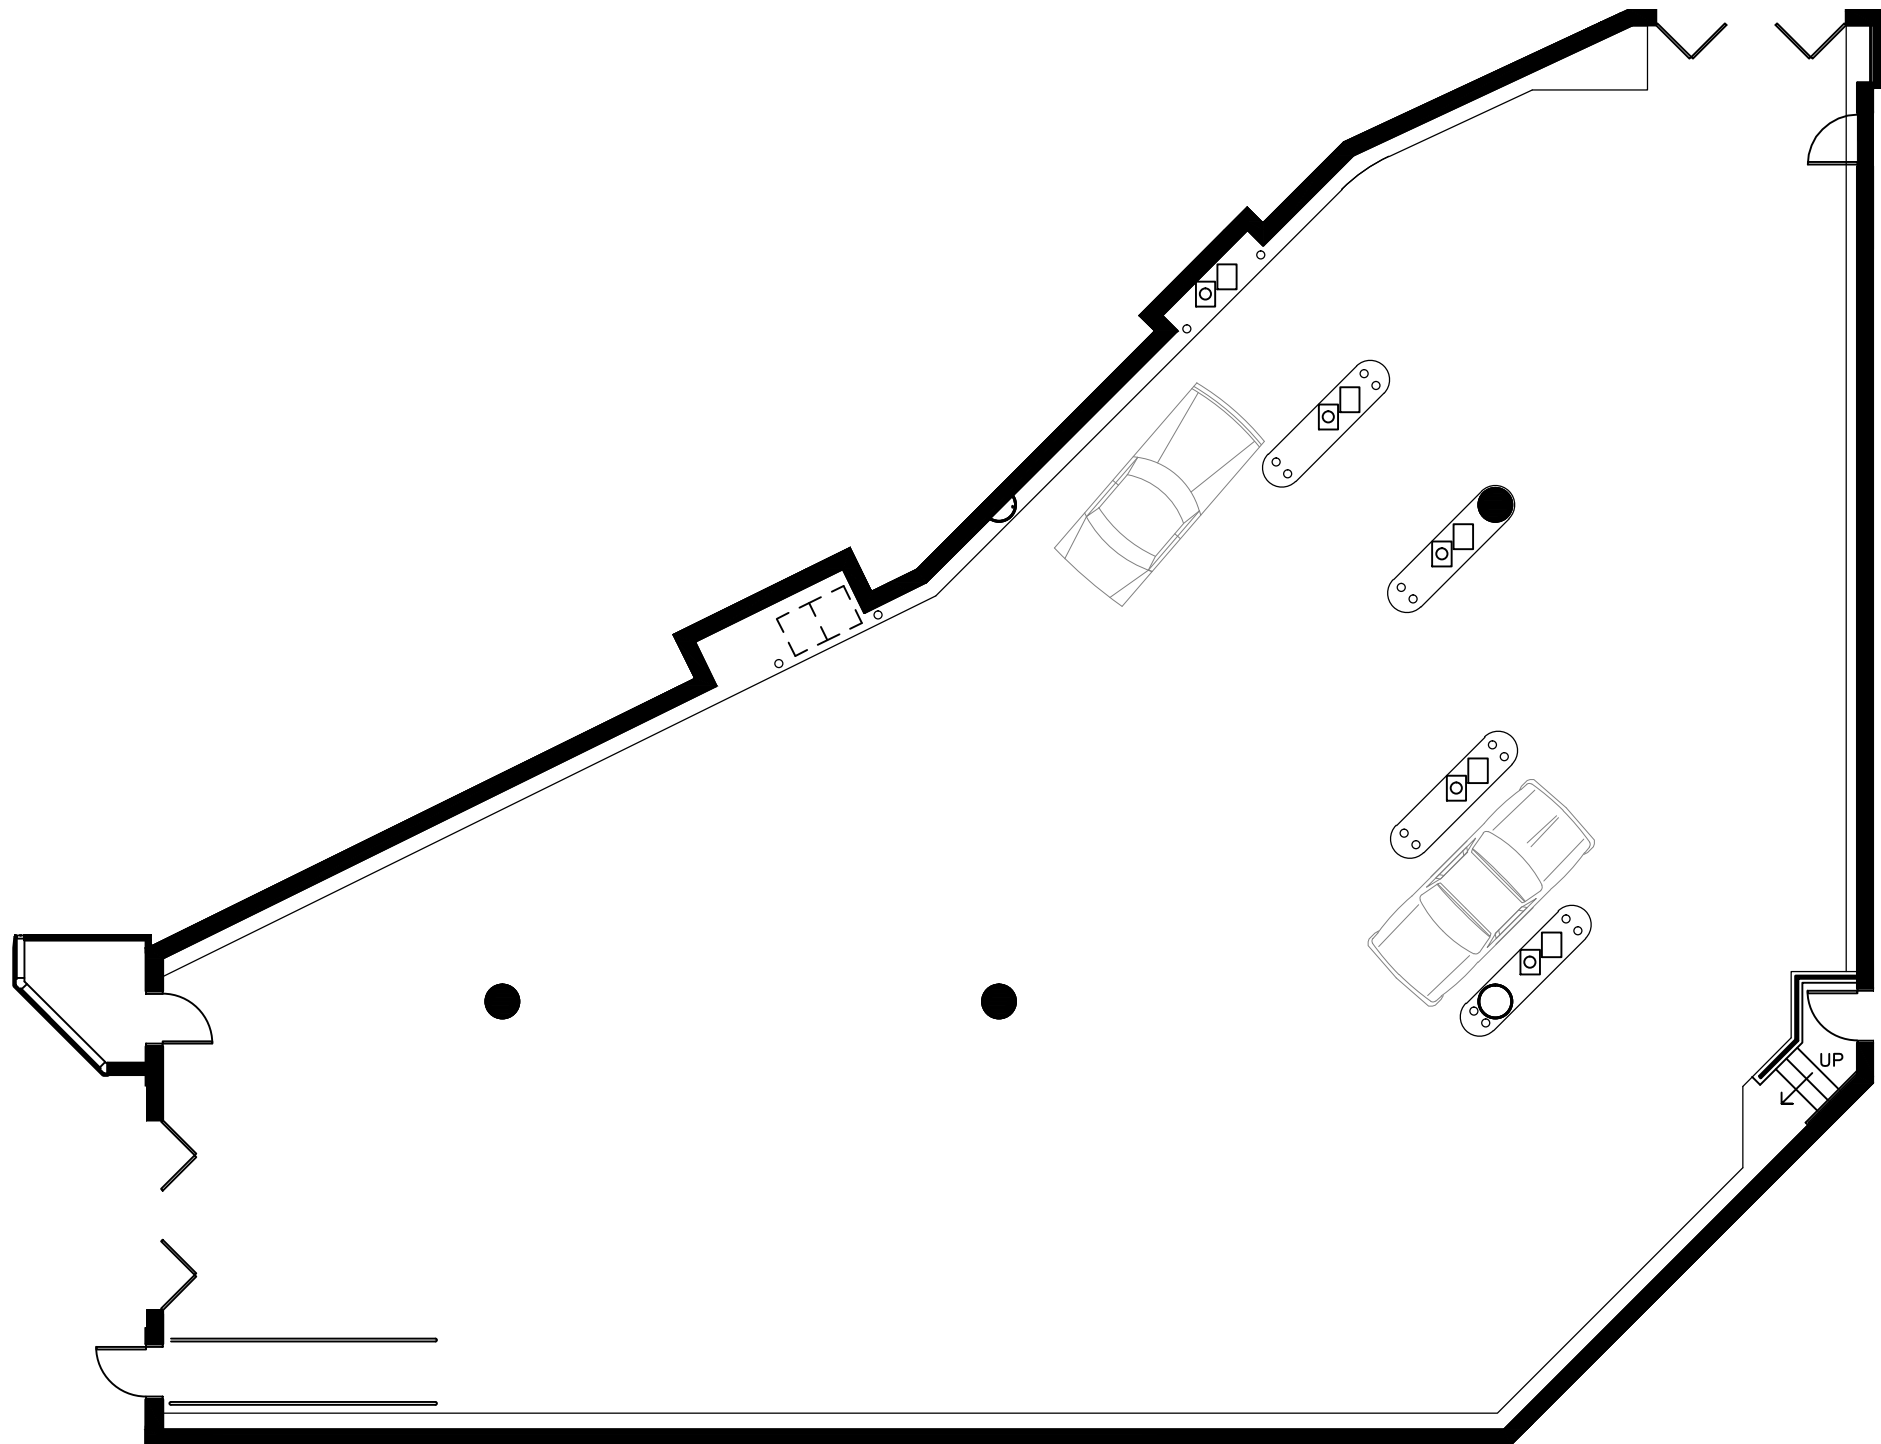

↑  
CATHEDRAL

↑  
MISSISSIPPI RIVER  
HIGH BRIDGE