


MINNEAPOLIS

CATHEDRAL

CAPITOL

MISSISSIPPI RIVER
HIGH BRIDGE

MISSISSIPPI RIVER
LAFAYETTE BRIDGE

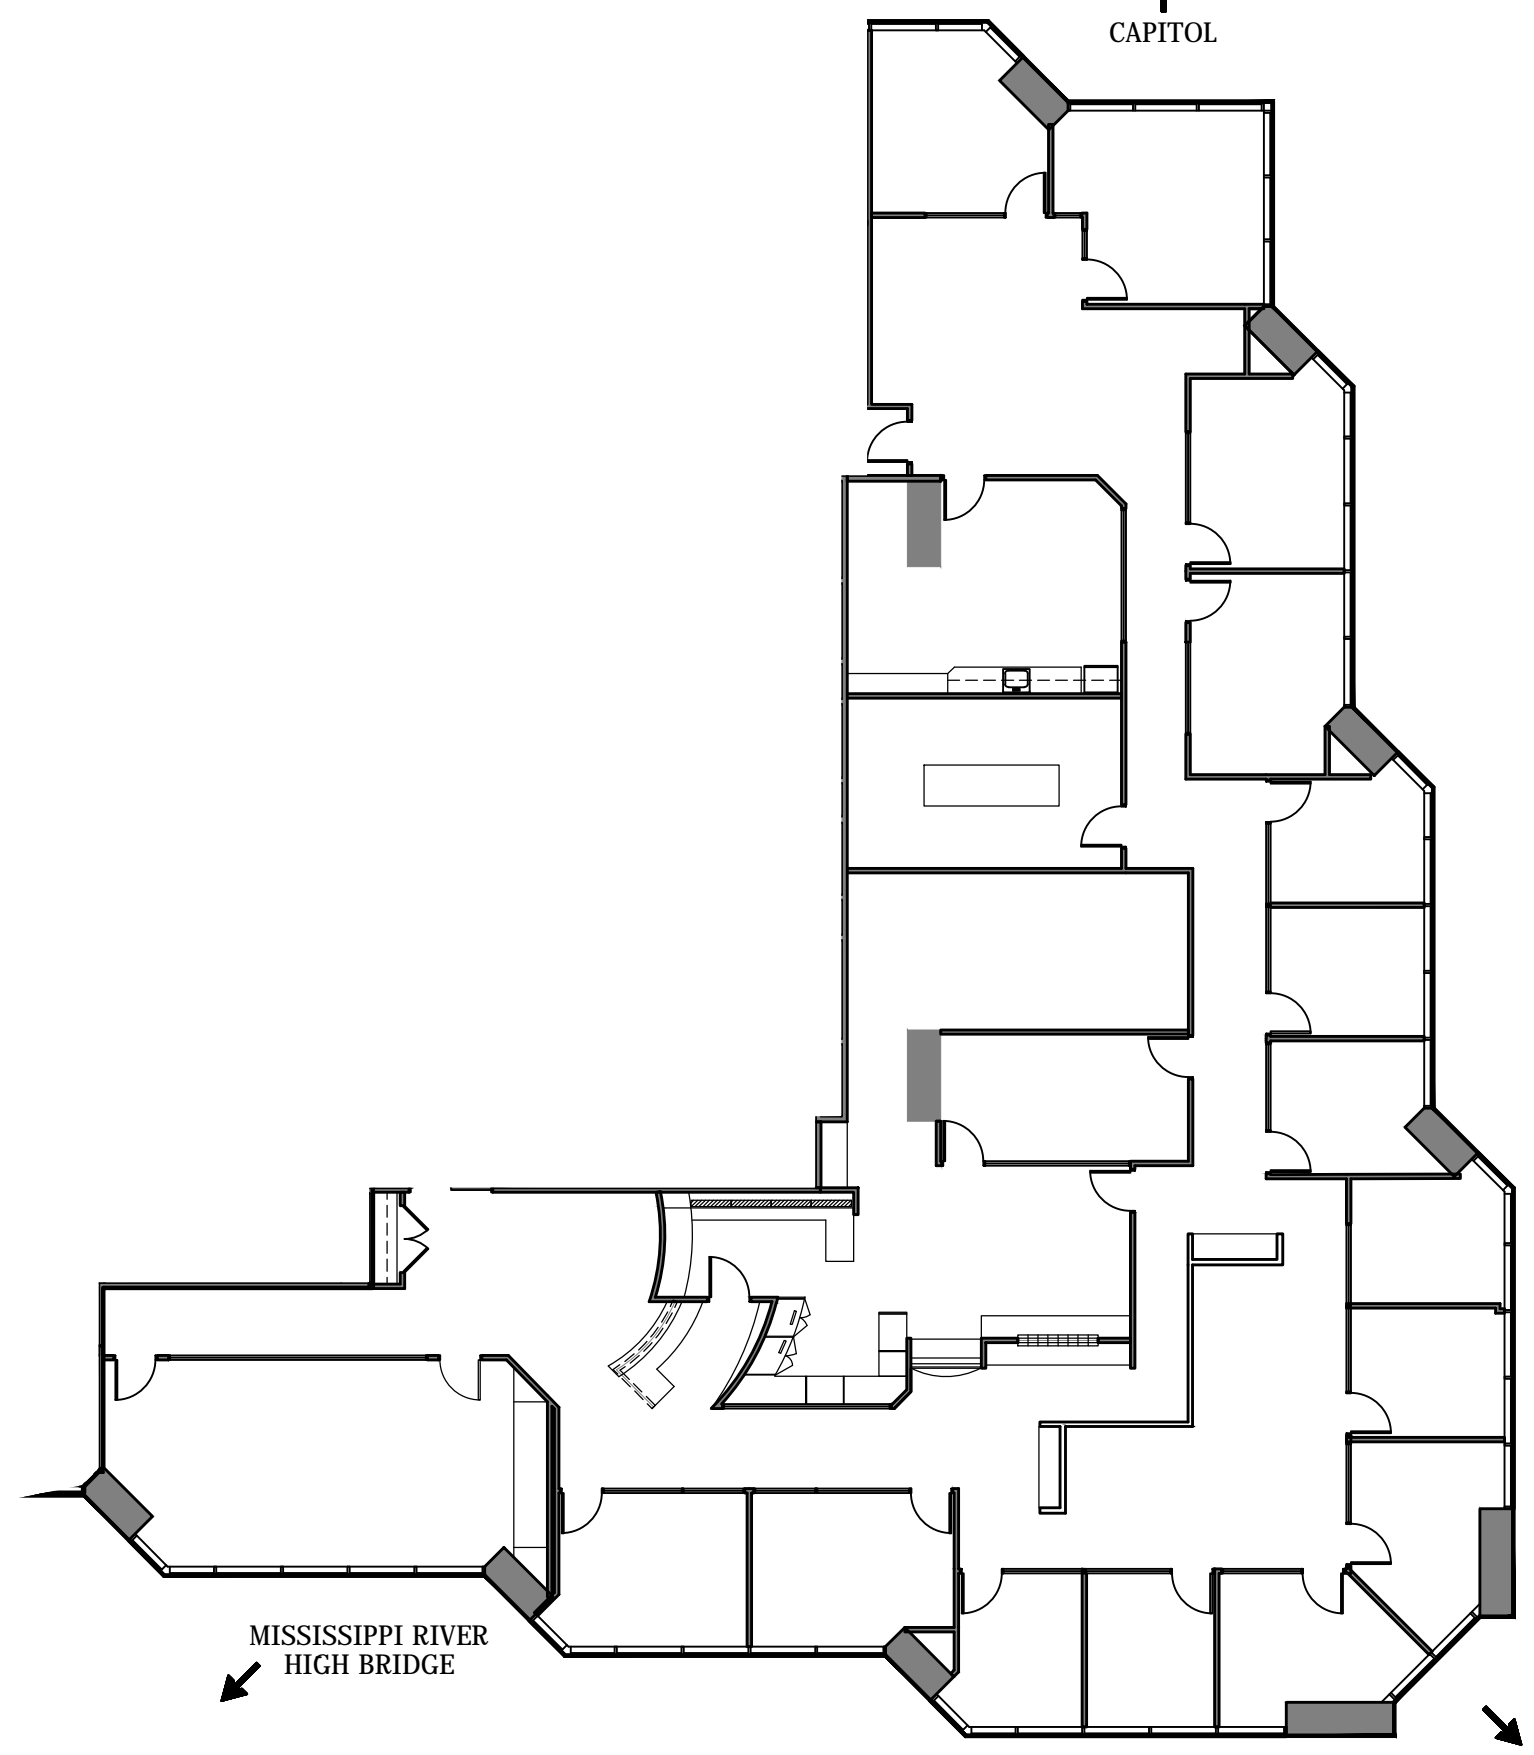


100 north sixth street
suite 650c
minneapolis, mn
55403-1594

T 612 339 2257
F 612 349 2930

www.shealink.com



UNILEV MANAGEMENT CORP

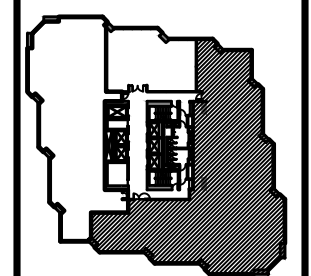

KEY PLAN
**AS-BUILT
FLOOR PLAN**
FLOOR 24
SUITE #2400
VACANT
6,607 USF
7,664 RSF

comm. no.: 6370.01

scale: NOT TO SCALE

date: 3.18.11

revision date:

drawn by:

AB-2400